




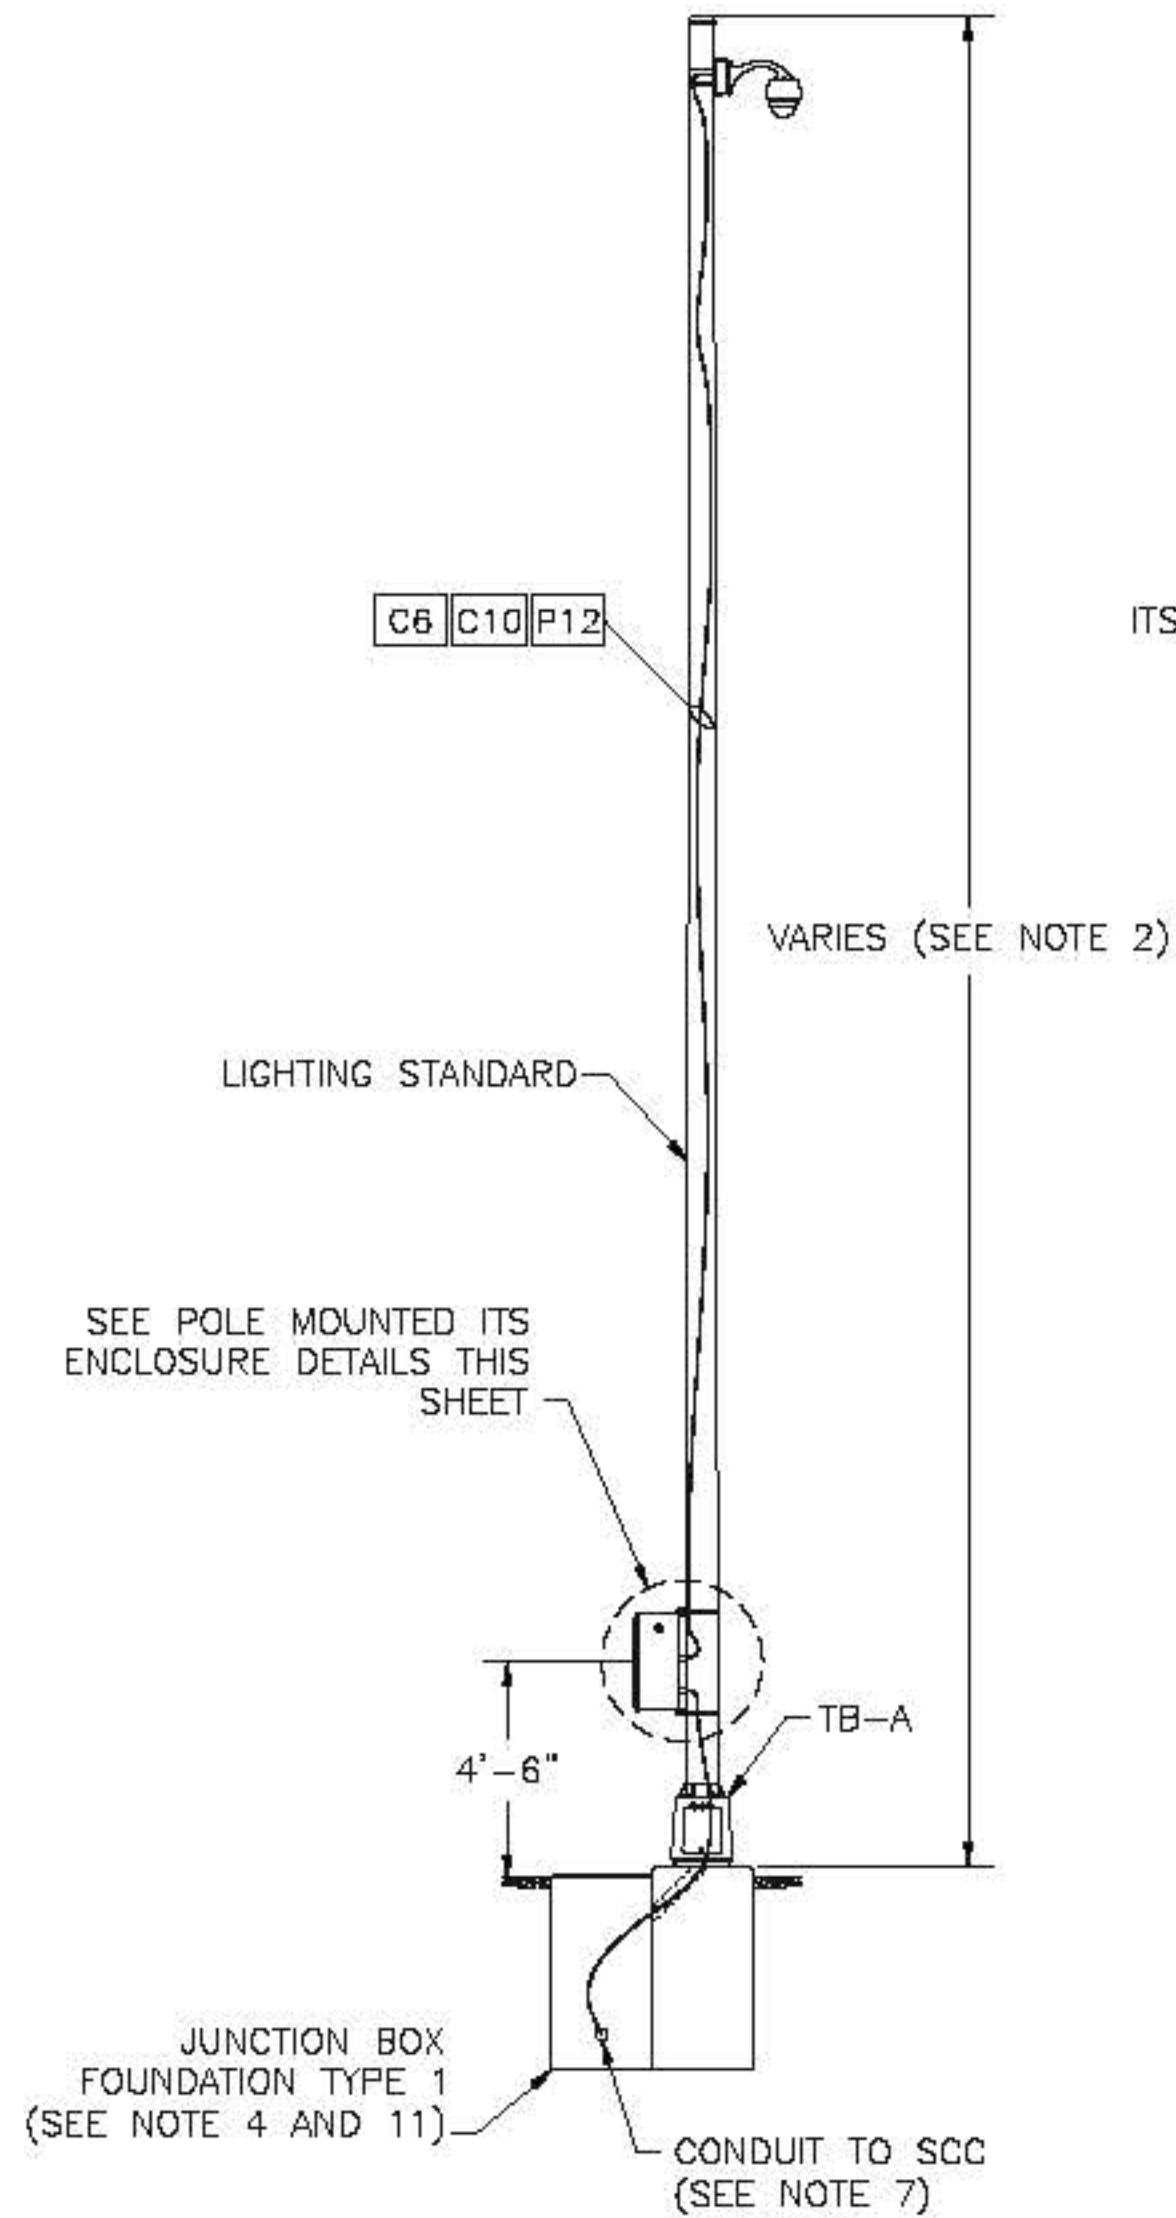


CCTV CAMERA POLE MOUNTED WITH ITS ENCLOSURE
SCALE: 1/4" = 1'-0"

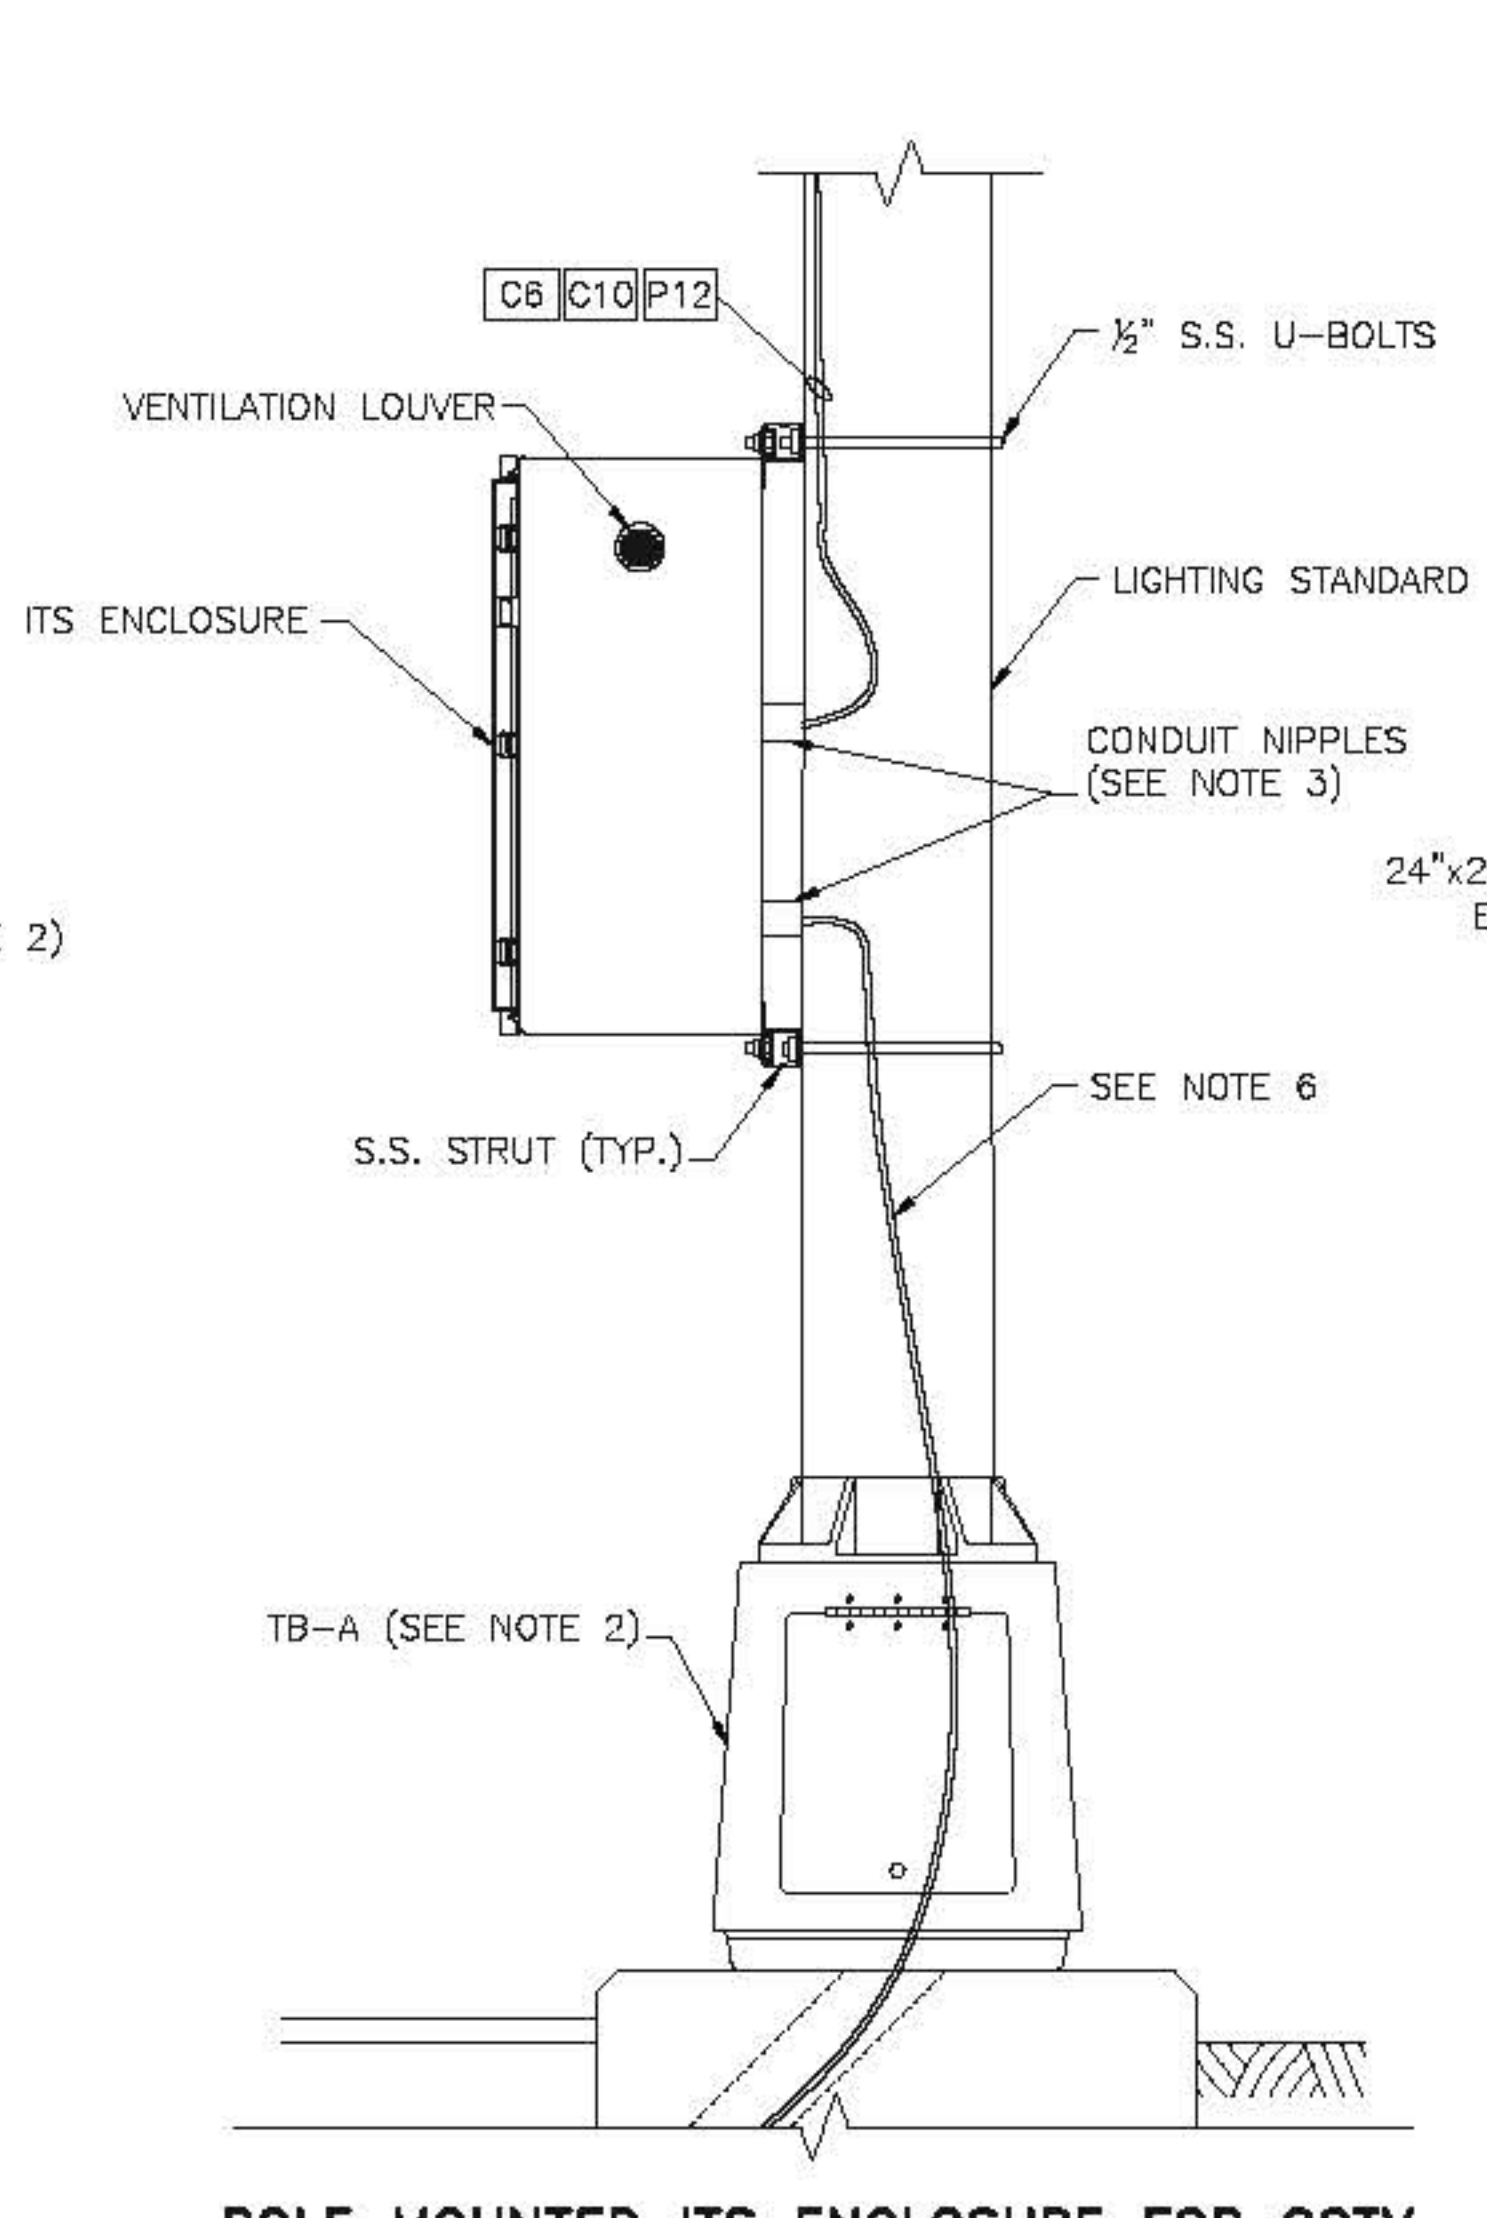


POLE MOUNTED ITS ENCLOSURE FOR CCTV CAMERA - SIDE ELEVATION
SCALE: 1/2" = 1'-0"

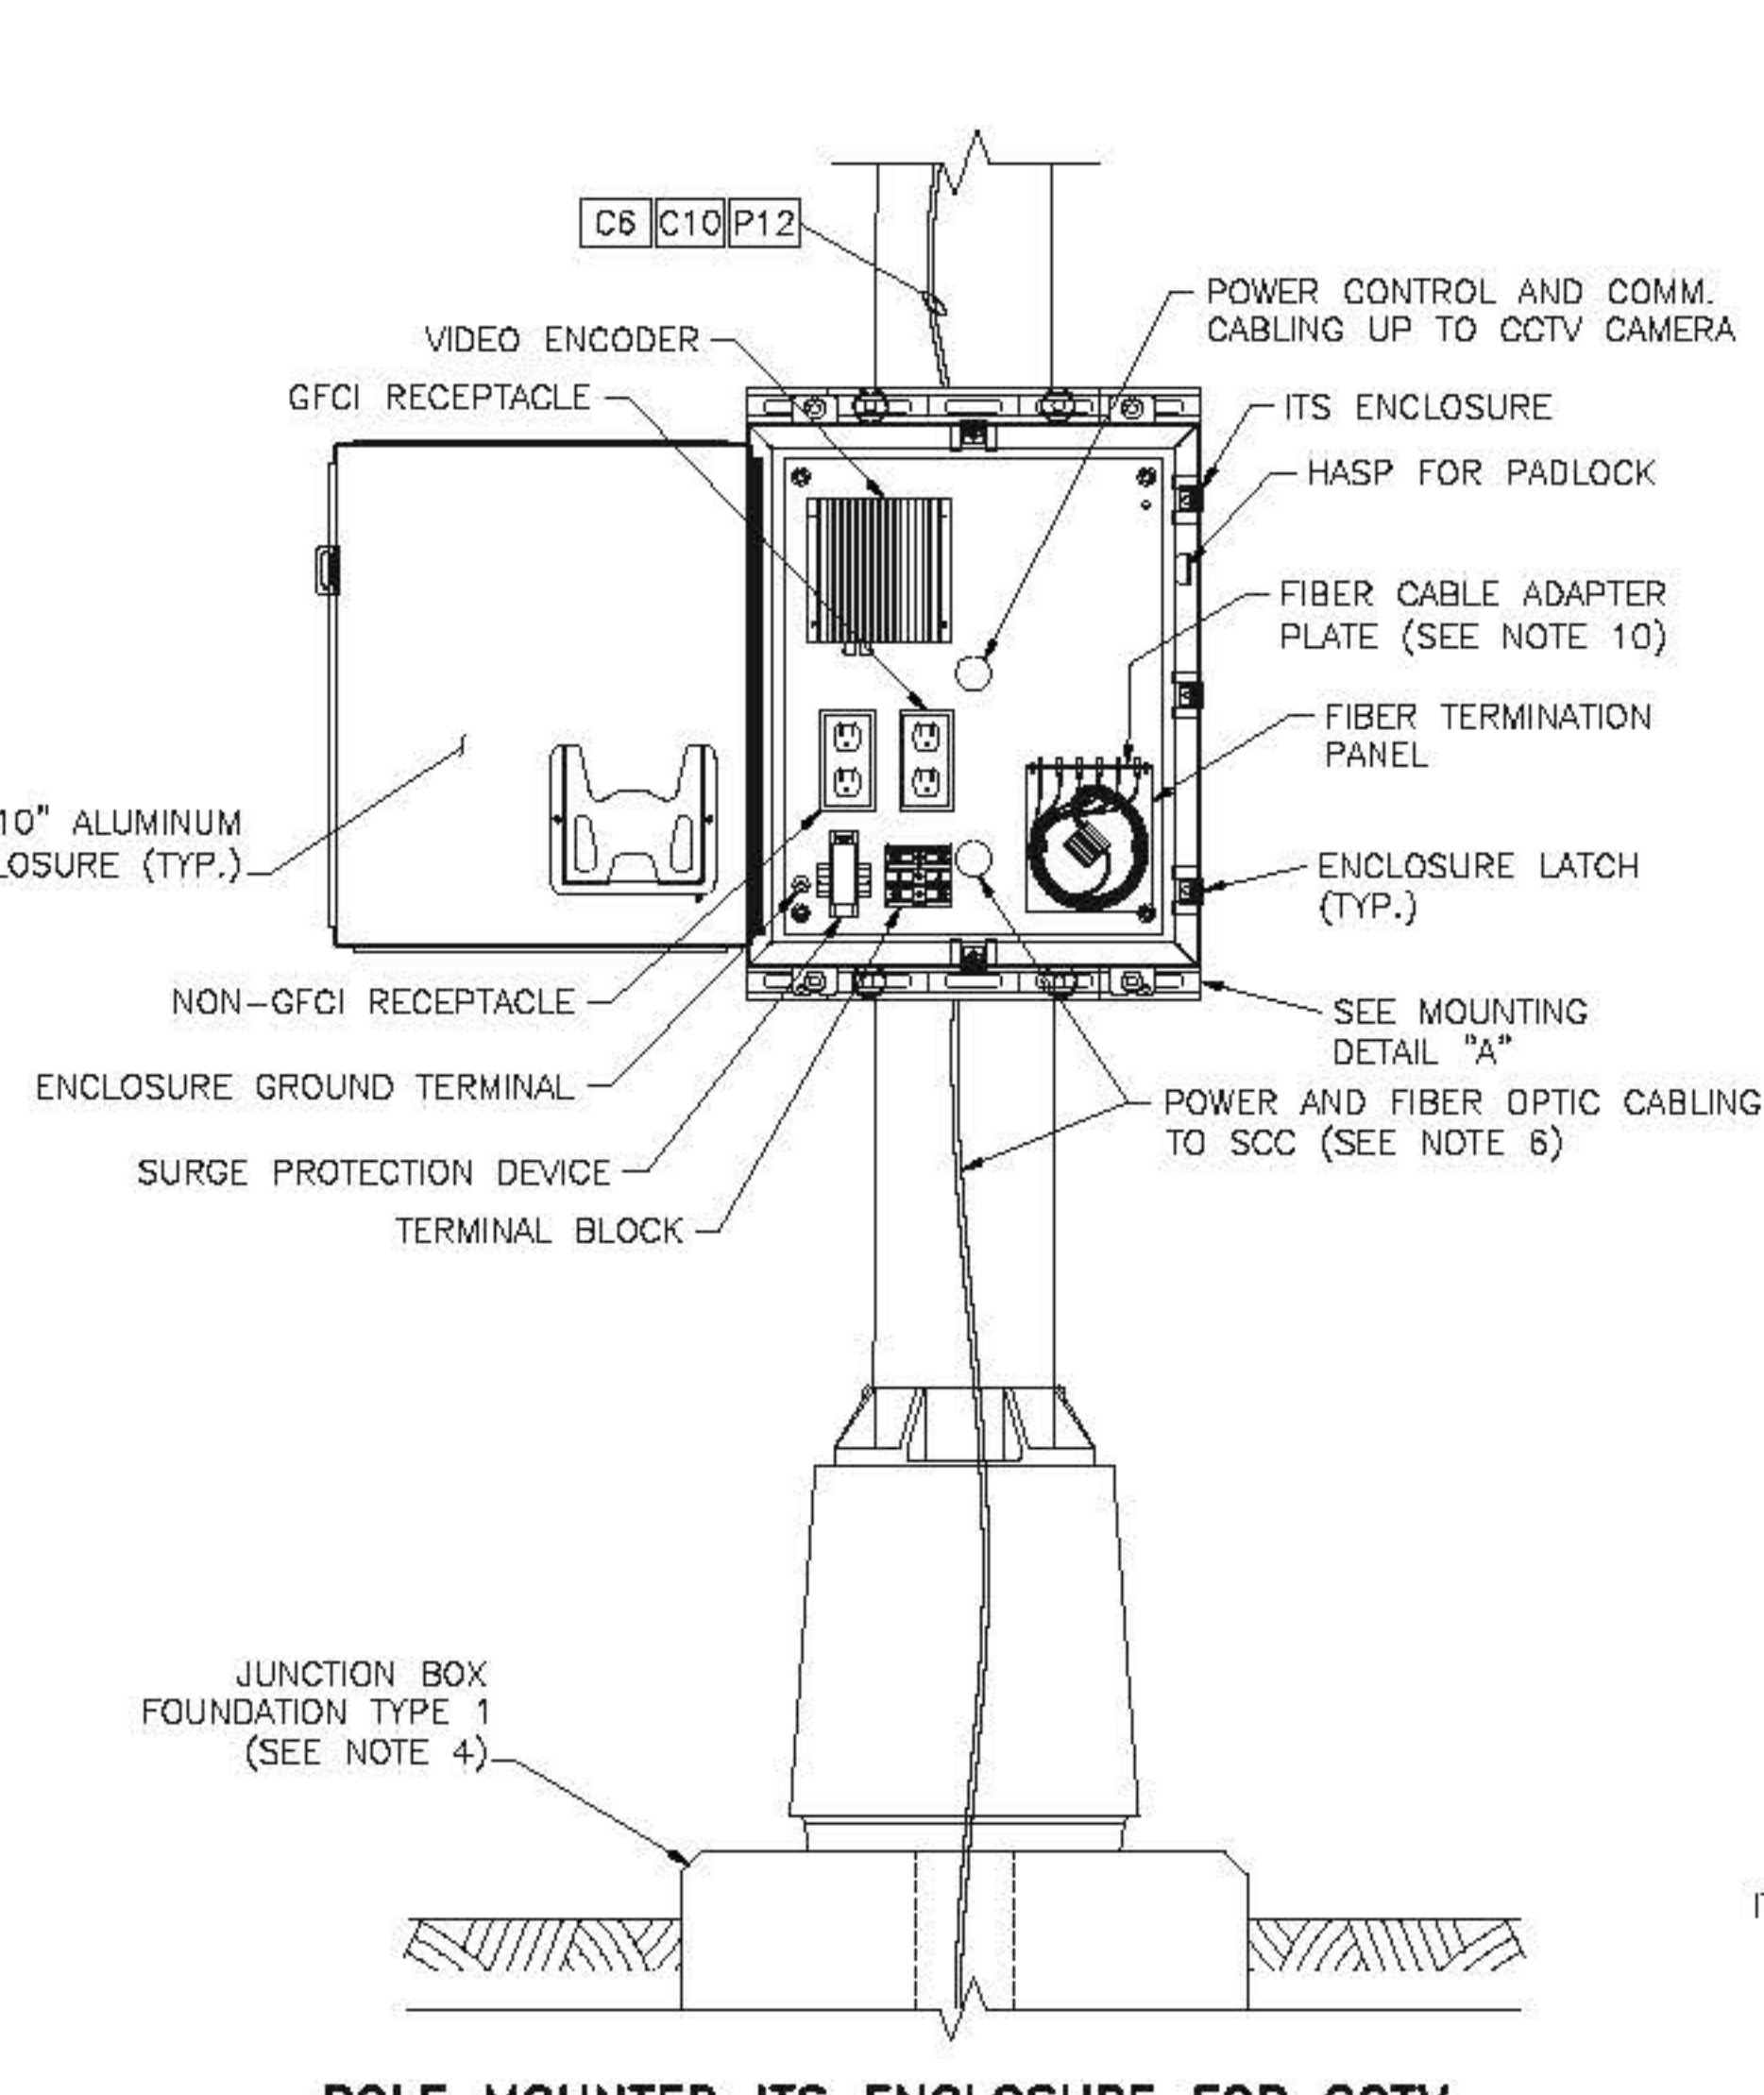

POLE MOUNTED ITS ENCLOSURE FOR CCTV CAMERA- FRONT ELEVATION
SCALE: 1/2" = 1'-0" (SEE NOTE 9)

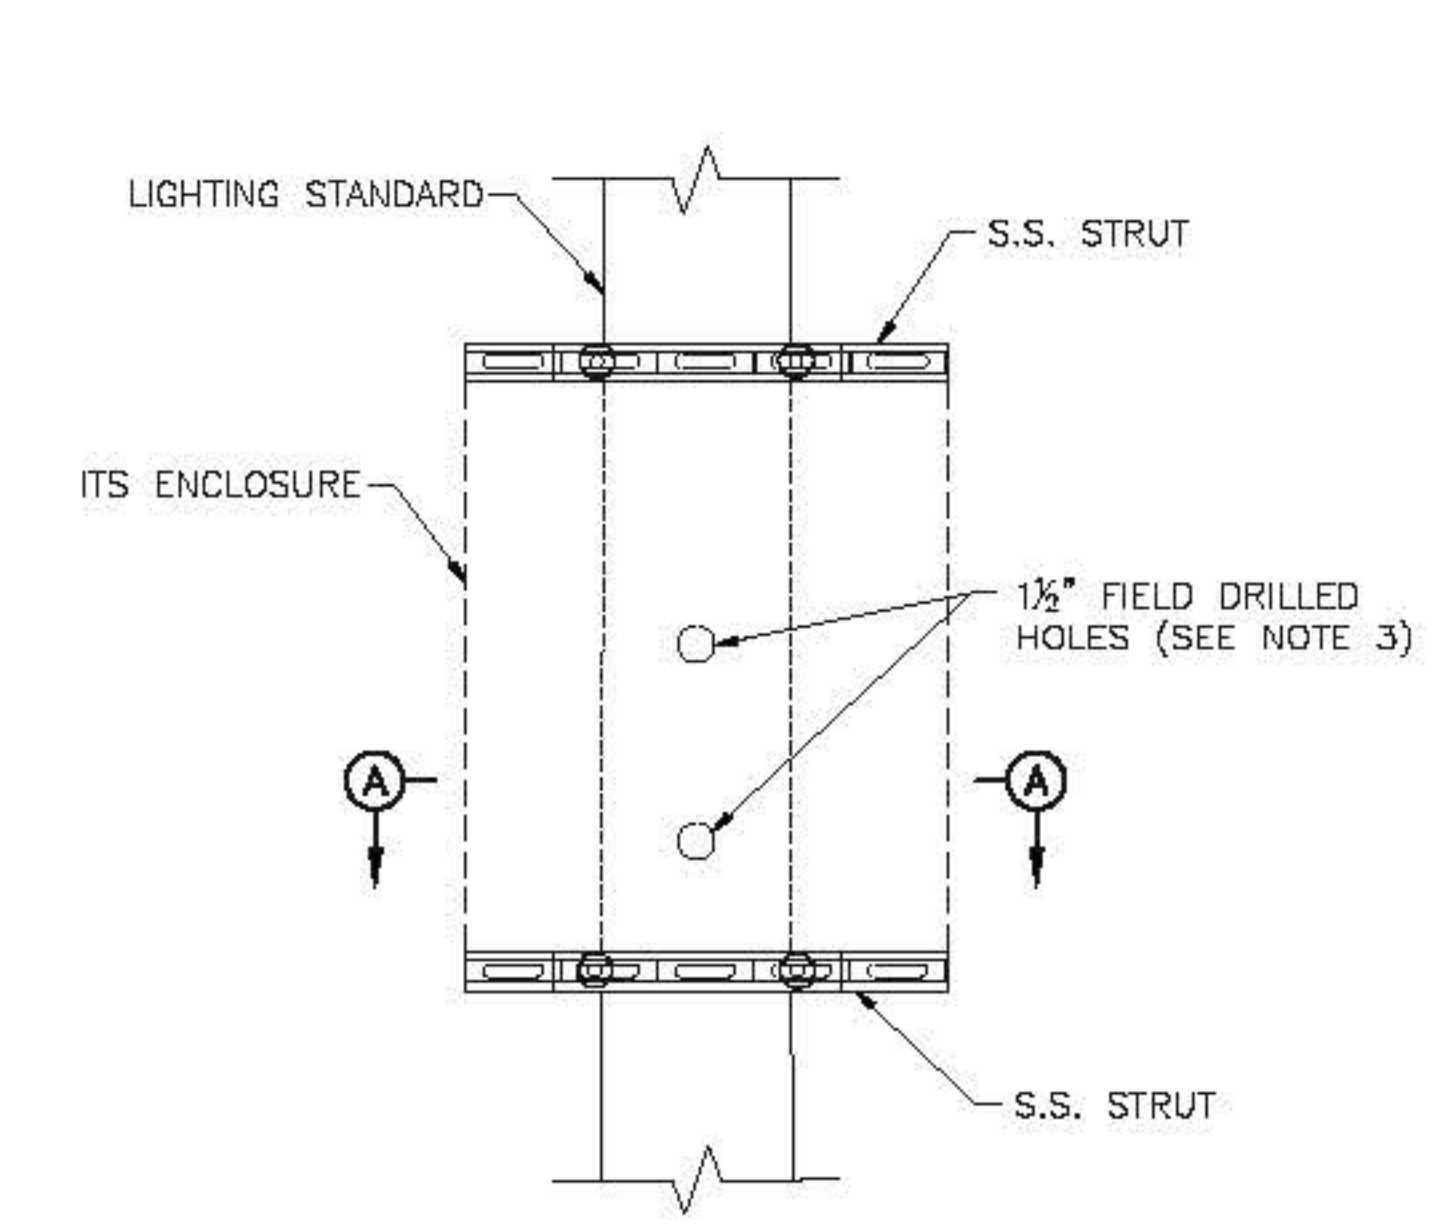

MOUNTING DETAIL A
SCALE: 1/2" = 1'-0"

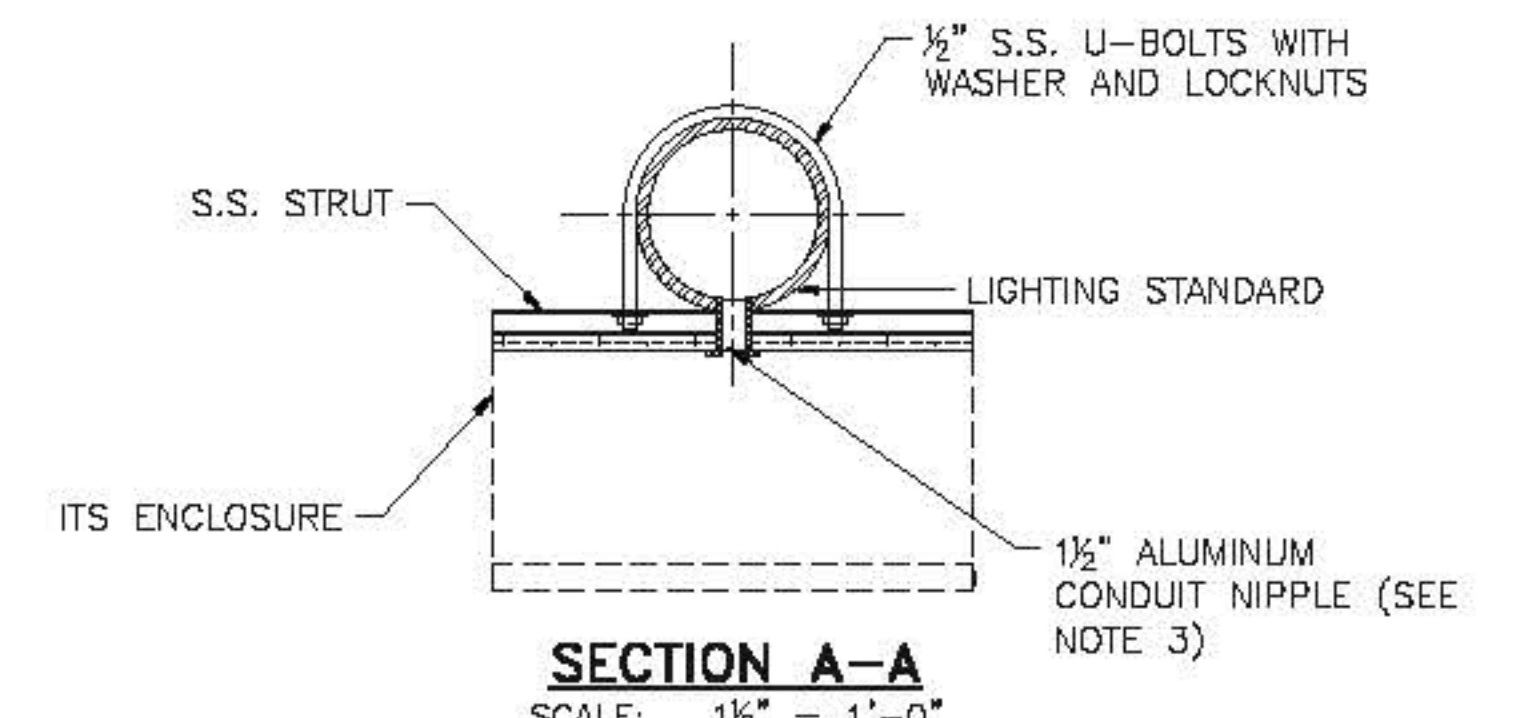


SECTION A-A
SCALE: 1/2" = 1'-0"

POLE MOUNTED ITS ENCLOSURE FOR CCTV CAMERA- MOUNTING DETAILS

NOTES:

1. FOR LEGEND, ABBREVIATIONS AND GENERAL NOTES SEE STANDARD DRAWING ITS-01 AND ITS-02.
2. SEE STANDARD DRAWINGS E-01 TO E-04 FOR LIGHTING STANDARD TYPES AND DETAILS. SEE THE CONTRACT PLANS FOR LOCATIONS AND TERMINATION POINTS AT SCCs.
3. THE ENCLOSURE SHALL BE SECURED TO THE POLE UTILIZING STAINLESS STEEL U-BOLTS. CABLING SHALL ENTER THROUGH FIELD DRILLED AND TAPPED 1" ALUMINUM CONDUIT NIPPLES. ALL OTHER HARDWARE SHALL BE STAINLESS STEEL UNLESS OTHERWISE NOTED. SEAL ALL AROUND CONDUIT TO PREVENT WATER FROM ENTERING ENCLOSURE.
4. FOR DETAILS OF JUNCTION BOX FOUNDATION TYPE 1, SEE STANDARD DRAWING E-12. FOR DETAILS OF TB-A SEE STANDARD DRAWING E-09.
5. INSTALLATION OF CCTV EQUIPMENT ON PARAPET SHALL BE SIMILAR BUT SHALL NOT INCLUDE A TRANSFORMER BASE.
6. SEE CONTRACT PLANS FOR TYPE AND ROUTING OF POWER AND COMMUNICATIONS CABLING TO THE SCC.
7. SEE CONTRACT PLANS FOR THE CONTINUATION AND CONFIGURATION OF CONDUITS.
8. FACE OF THE ENCLOSURE SHALL BE LOCATED AS SHOWN ON THE DETAILS DELINEATED ON THIS DRAWING.
9. ARRANGEMENT OF EQUIPMENT WITHIN THE CCTV CAMERA POLE MOUNTED ITS ENCLOSURE IS DIAGRAMMATIC. FINAL PLACEMENT MAY REQUIRE MODIFICATIONS BASED ON EQUIPMENT APPROVED FOR USE.
10. PROVIDE FIBER JUMPER CABLES AND SC FIBER CONNECTORS TO CONNECT EQUIPMENT IN ENCLOSURE TO FIBER TERMINATION PANEL AS REQUIRED.
11. POLE AND ENCLOSURE SHALL BE GROUNDED. SEE GROUND AND INSTALLATION DETAILS ON NJTA STANDARD DWG E-09 AND E-12.

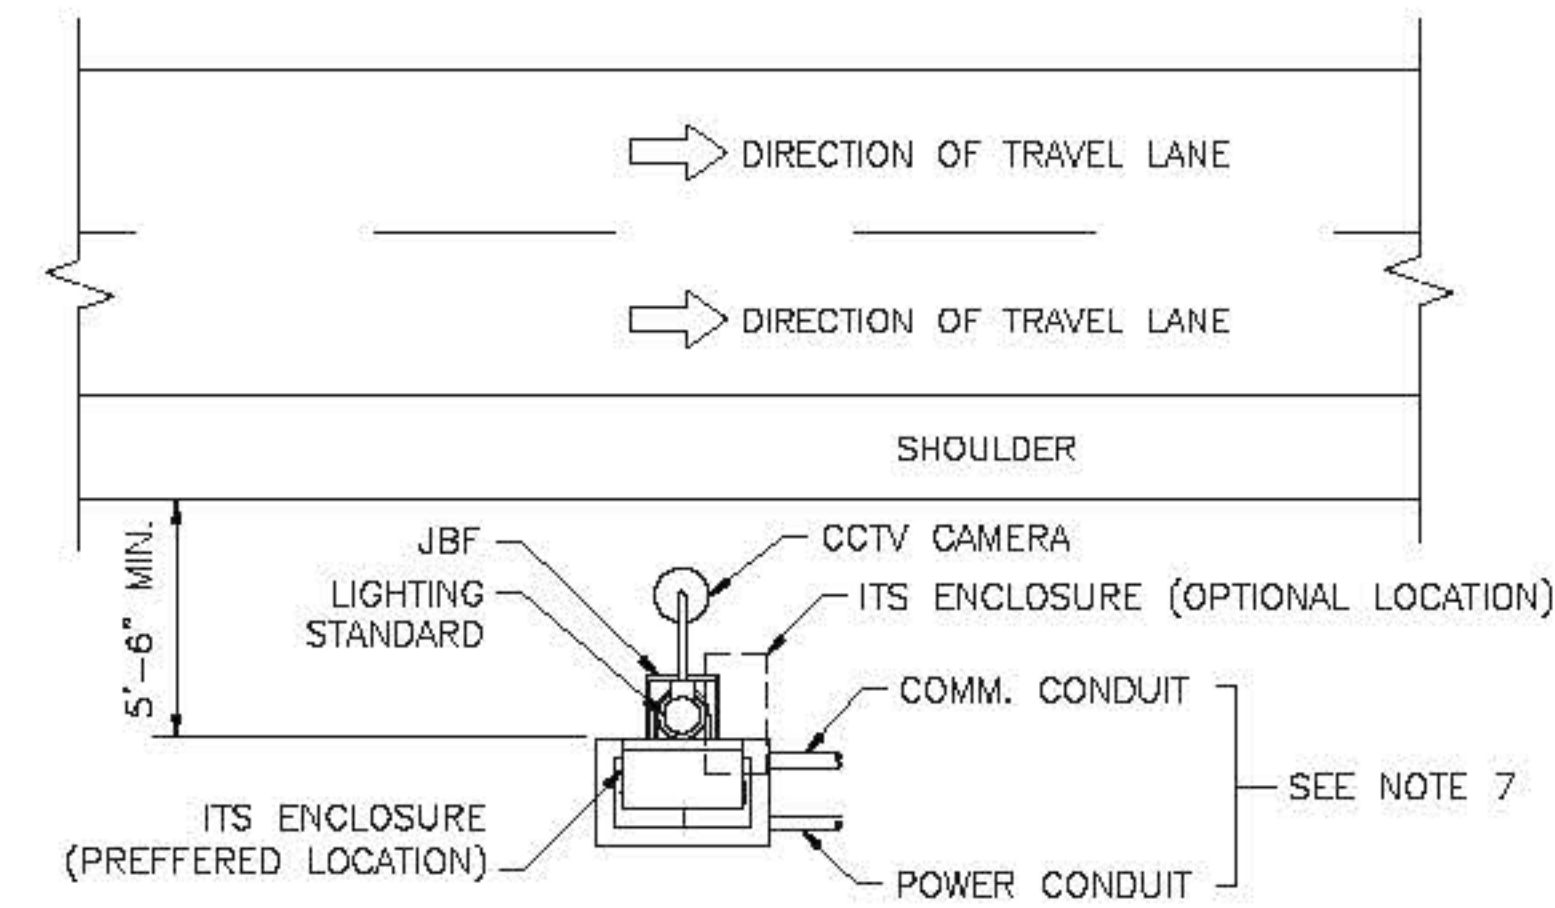

CCTV CAMERA AND ITS ENCLOSURE PLAN VIEW
N.T.S.



ORIGINAL SIZE IN INCHES

NEW JERSEY TURNPIKE AUTHORITY	
NEW JERSEY TURNPIKE	
CCTV CAMERA - 40FT POLE INSTALLATION DETAILS	
HNTB 9 ENMIN ROAD, SUITE 202, PARLISPPANY, NJ 07054 - COA# 24028000700 ANTHONY L. BARTELLO New Jersey Professional Engineer License No. 0E 40202	
STANDARD DRAWING	ITS-32

	BY	DATE
MADE	DR	08/2010
TRACED	GMS	08/2010
CHECKED	MS	08/2010
SUPERVISED	ALB	08/2010

APP.	NO.	DATE	REVISION
C	10/2013	CONFORMED DRAWING	