


No.	DATE	SAMPLE PLAN REVISION
0	5-08	ORIGINAL SHEET

	BY	DATE
MADE	XXX	XX-XX-XX
TRACED	XXX	XX-XX-XX
CHECKED	XXX	XX-XX-XX
SUPERVISED	X.XXXX	

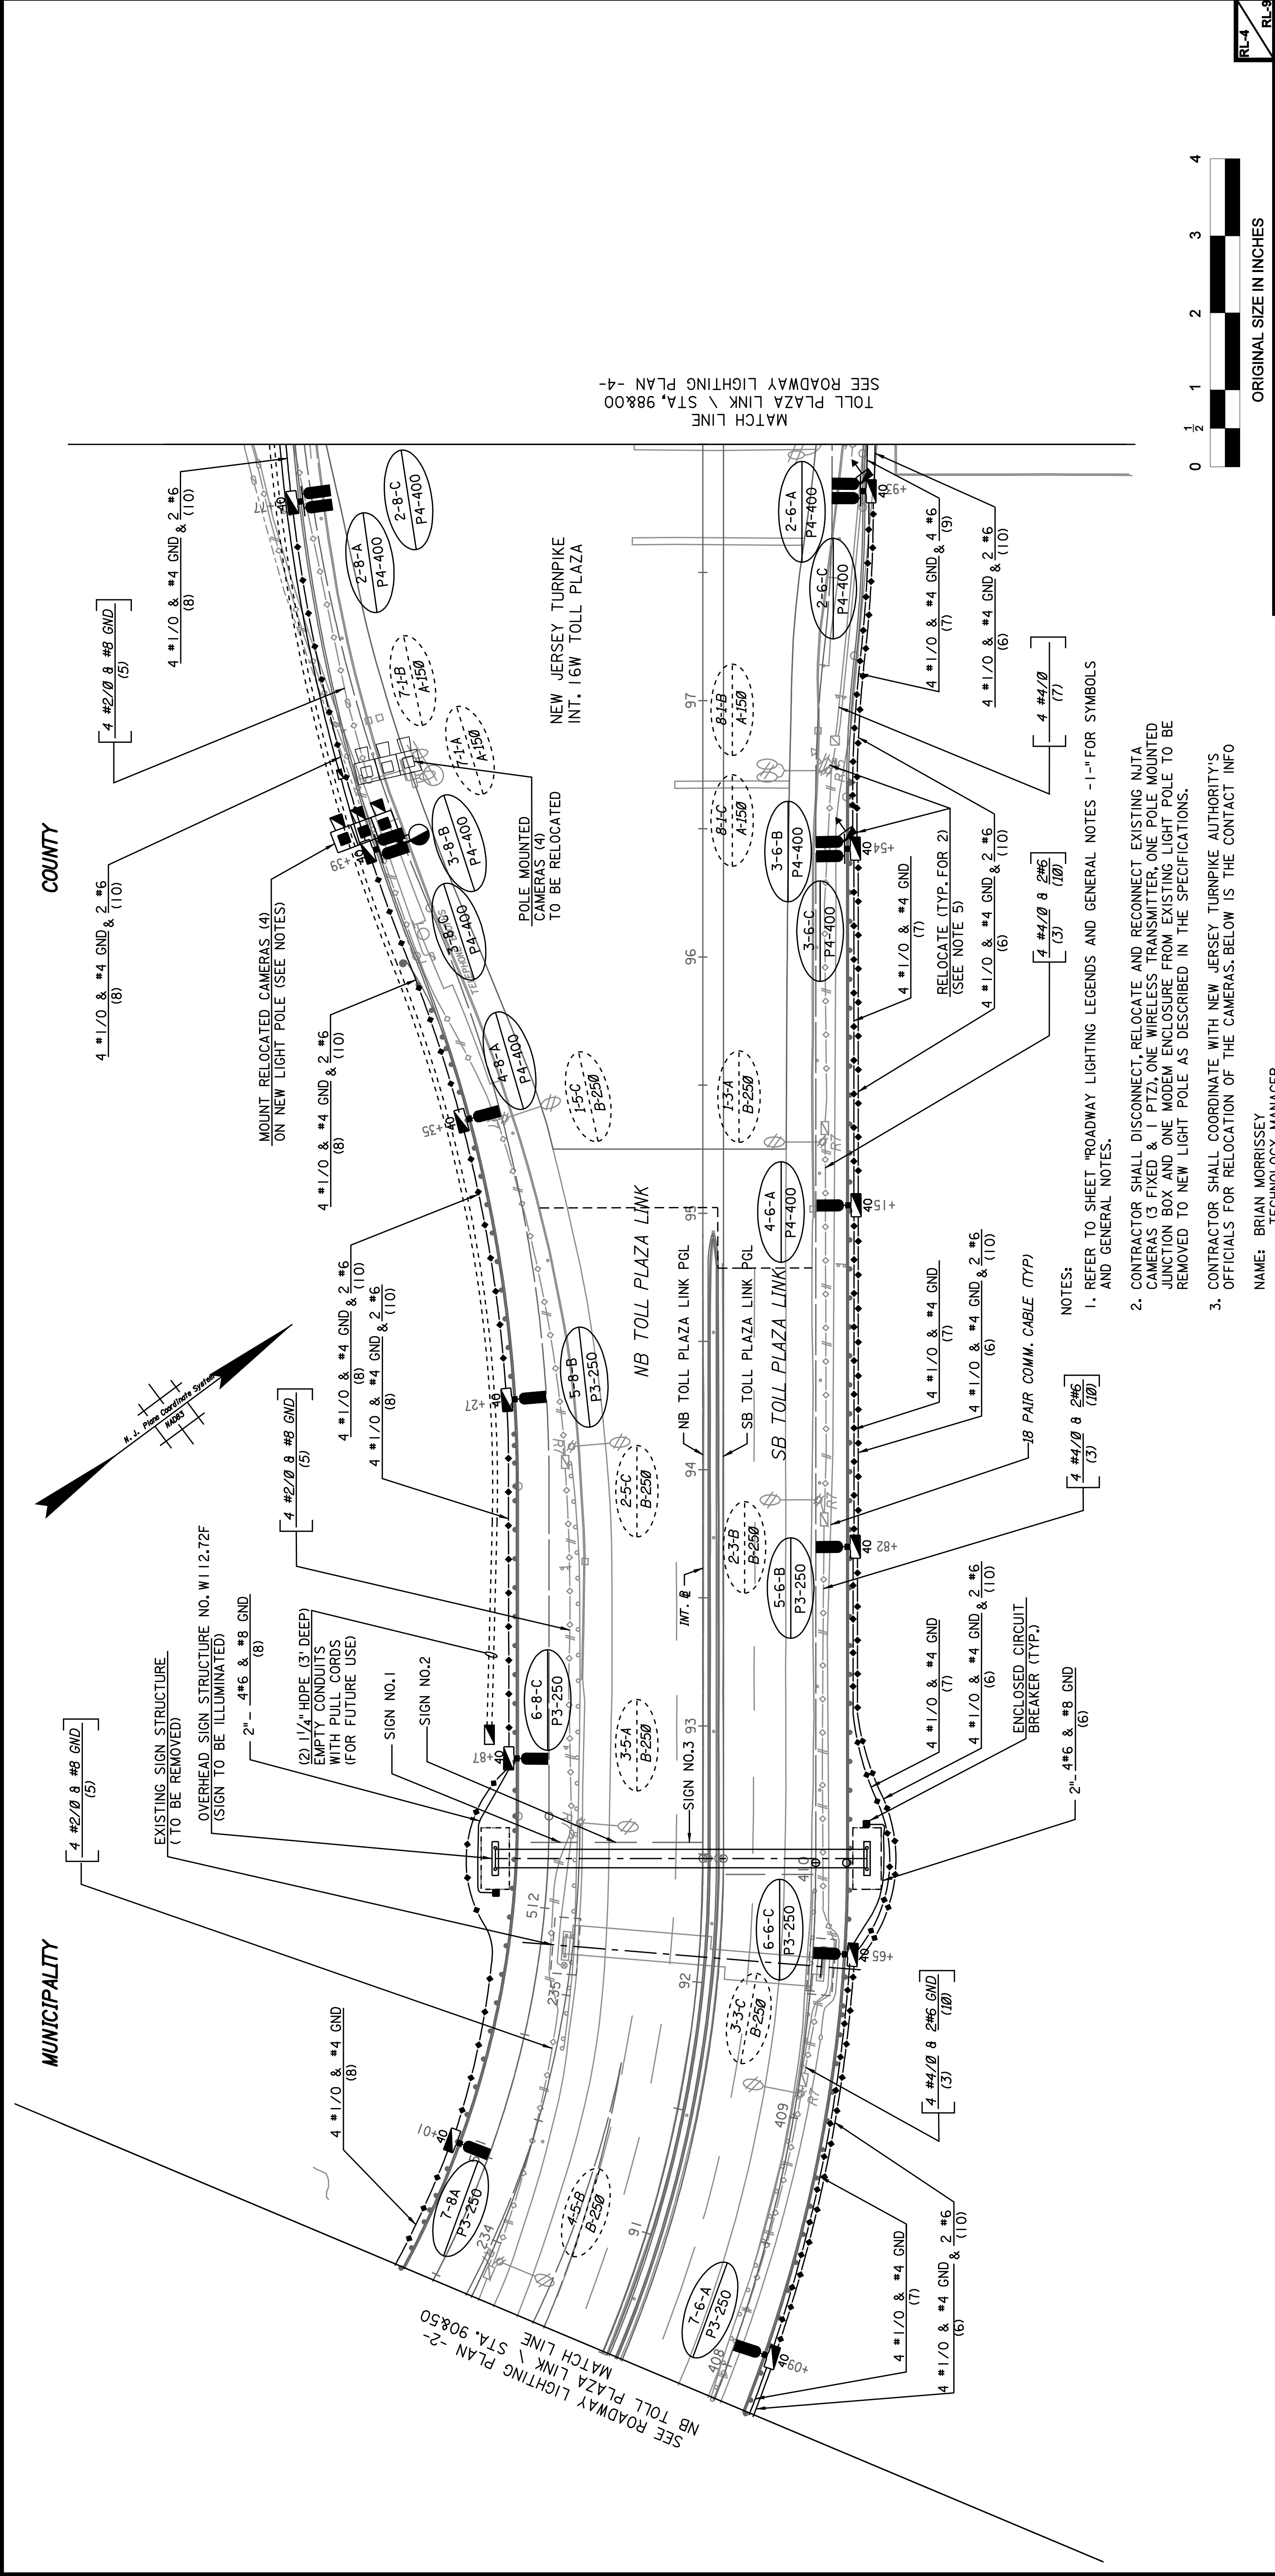

NEW JERSEY TURNPIKE AUTHORITY	
ROADWAY NAME	
PROJECT DESCRIPTION	
CONTRACT NO.	
ROADWAY LIGHTING PLAN -3-	
NAME OF CONSULTANT	
ADDRESS	
CERTIFICATE OF AUTHORIZATION NO. XXXXXXXXXX	
SCALE: 1" = 30'	
DATE: MAY 2008	

JOHN DOE	
NEW JERSEY PROFESSIONAL ENGINEER LICENSE NO. XXXXXXXXXXXXXXXX	

No.	DATE	REVISION

FILE NAME: XXXX